



# Studio B Production Floor Plan

650 Square metres - 32.5m x 20m

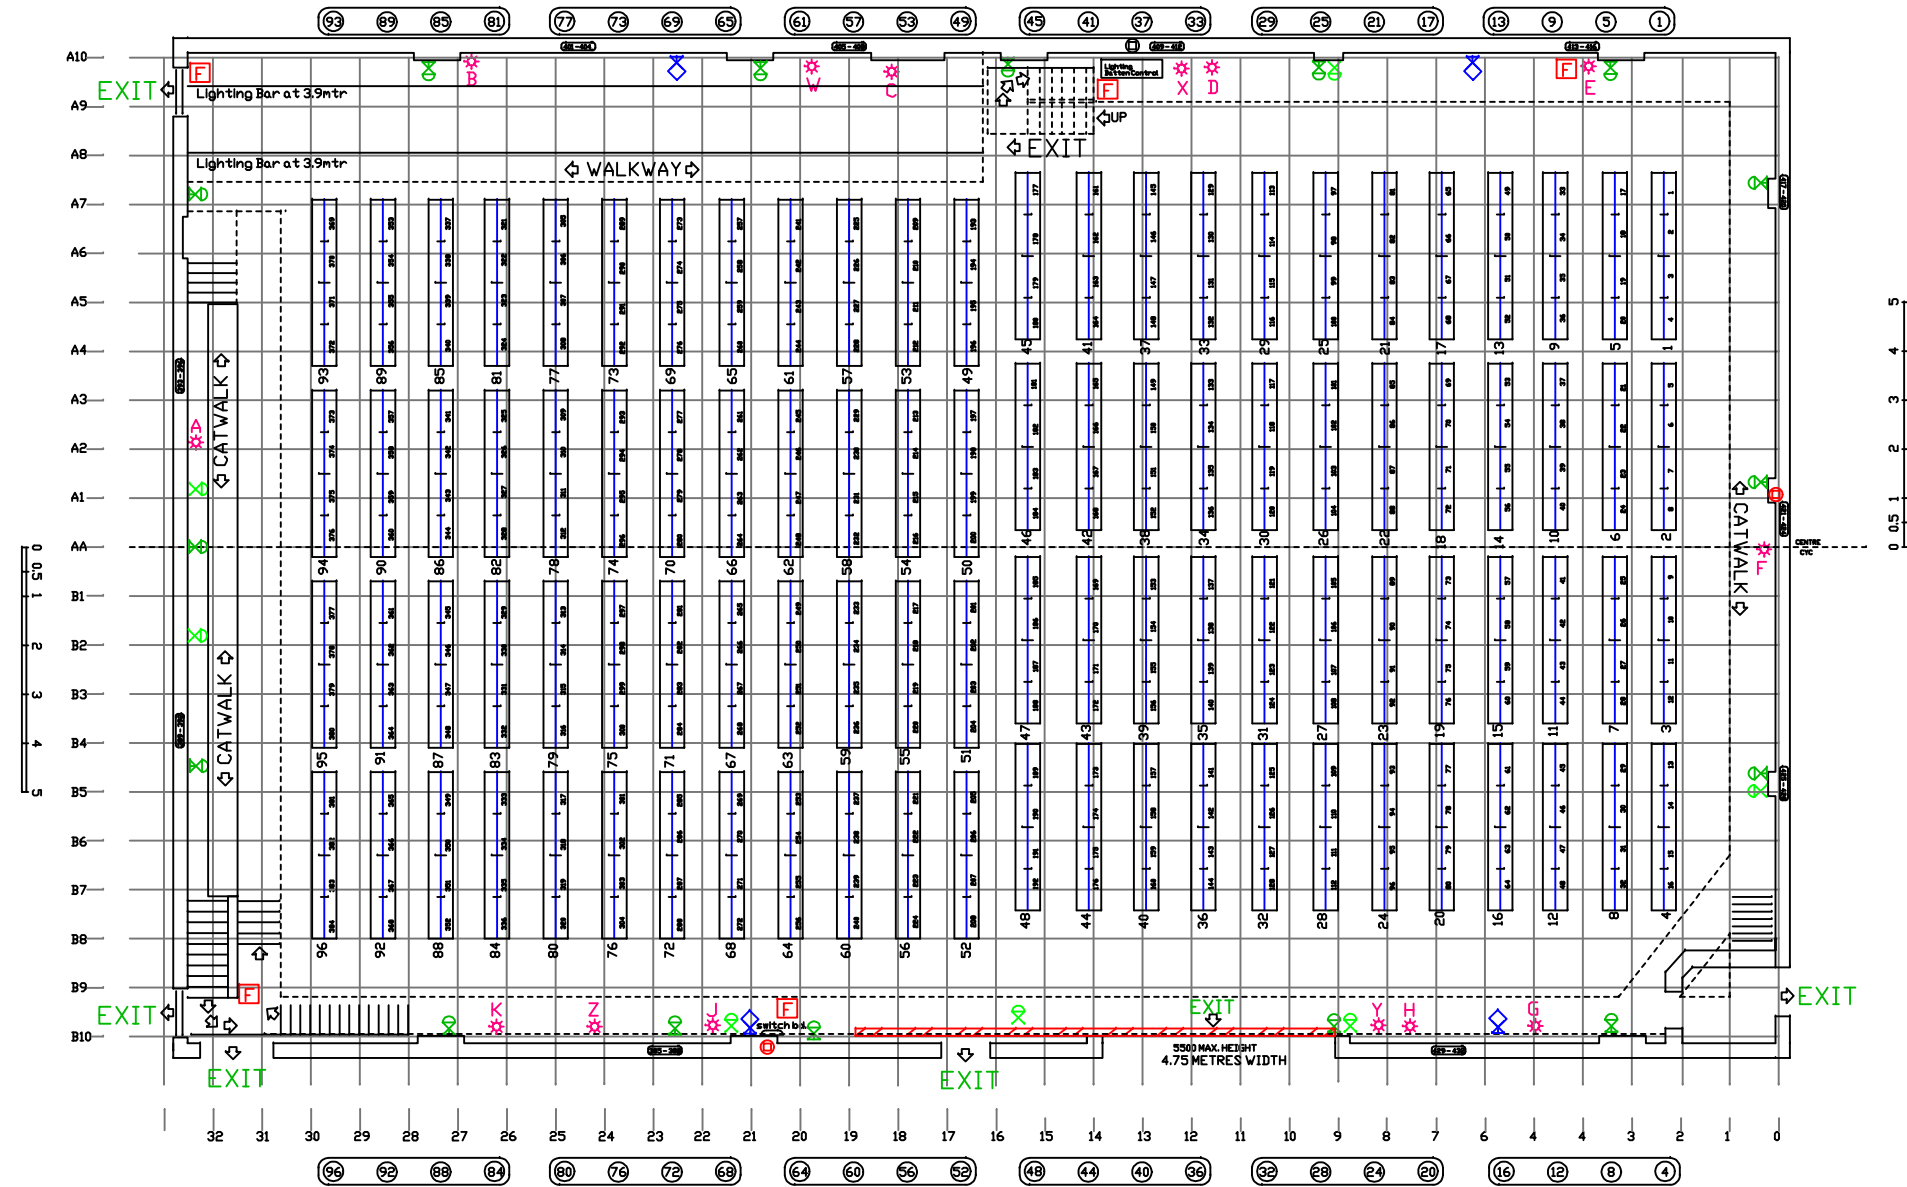

scale 1:50 0 0.5 1 2 3 4 5

 audio wall box a > v	Lighting Batters in control groups
4 x 15A 240V outlet - floor level	3 PHASE OUTLETS
2 x 15A 240V outlet - gallery	FIRE EXTINGUISHER
EMERGENCY STOP buttons	Gallery Line



Designed by xxx	Checked by xxx	Approved by xxx	Filename NEP	Date 17-5-2016	Scale xxx
			Title: <b>STUDIO B FLOOR PLAN</b>		
Drawing No: xxx			Edition: x Sheet: 1 of 1		